

ELK HOUSE INTERIORS

The Studio
Knockrath
Church Lane,
Greystones - Co. Wicklow
A63 KD40


REVISIONS

REV	DATE	COMMENTS
A	16/05/23	REVISED ELECTRICALS
	13/04/23	ISSUED FOR INFORMATION


COMMENTS:

ON GROUND FLOOR THE KITCHEN DESIGN HAS BEEN UPDATED.
ELECTRICAL LAYOUT HAS BEEN REVISED ACCORDINGLY.
CLIENTS TO CONFIRM IF KITCHEN WINDOW IS TO BE REMOVED
FROM PLANS
***ELECTRICIAN TO CONFIRM LAYOUT*.**

EHI ADDITIONAL RCP LEGEND		ELECTRICAL LEGEND:	
	SPOTLIGHT		FUSE BOARD
	BATHROOM SPOTLIGHT		HEAT DETECTOR
	PENDANT		SMOKE DETECTOR
	STRIP LIGHT		COOKER SWITCH
	DEMISTER PADS FOR MIRRORS		HEATING CONTROLS
			PENDANT LIGHT
			EXTERNAL WALL LIGHT TBC
			WALL MOUNTED LIGHT (own switch point)
			PHONE POINT
			TV POINT
			DOUBLE SOCKET (Double Pole Isolation Switch Under Counters)
			OVER COUNTER DOUBLE SOCKETS
			SINGLE SOCKET
			DOOR BELL
			RECESSED LED CEILING LIGHTS (waterproof fittings in bathroom areas)
			PICTURE LIGHT FITTING (OWN SWITCH)
			CARBON MONOXIDE DETECTOR
			SINGLE LIGHT SWITCH
			DOUBLE LIGHT SWITCH
			MECHANICAL VENTILATION (cooker hood)
			CEILING FAN (to central extract system)
			EXTERNAL SOCKET
			ESB PANEL
			ELECTRIC SHOWER
			LD2 FIRE ALARM PANEL
			WALL VENT (150mm min)

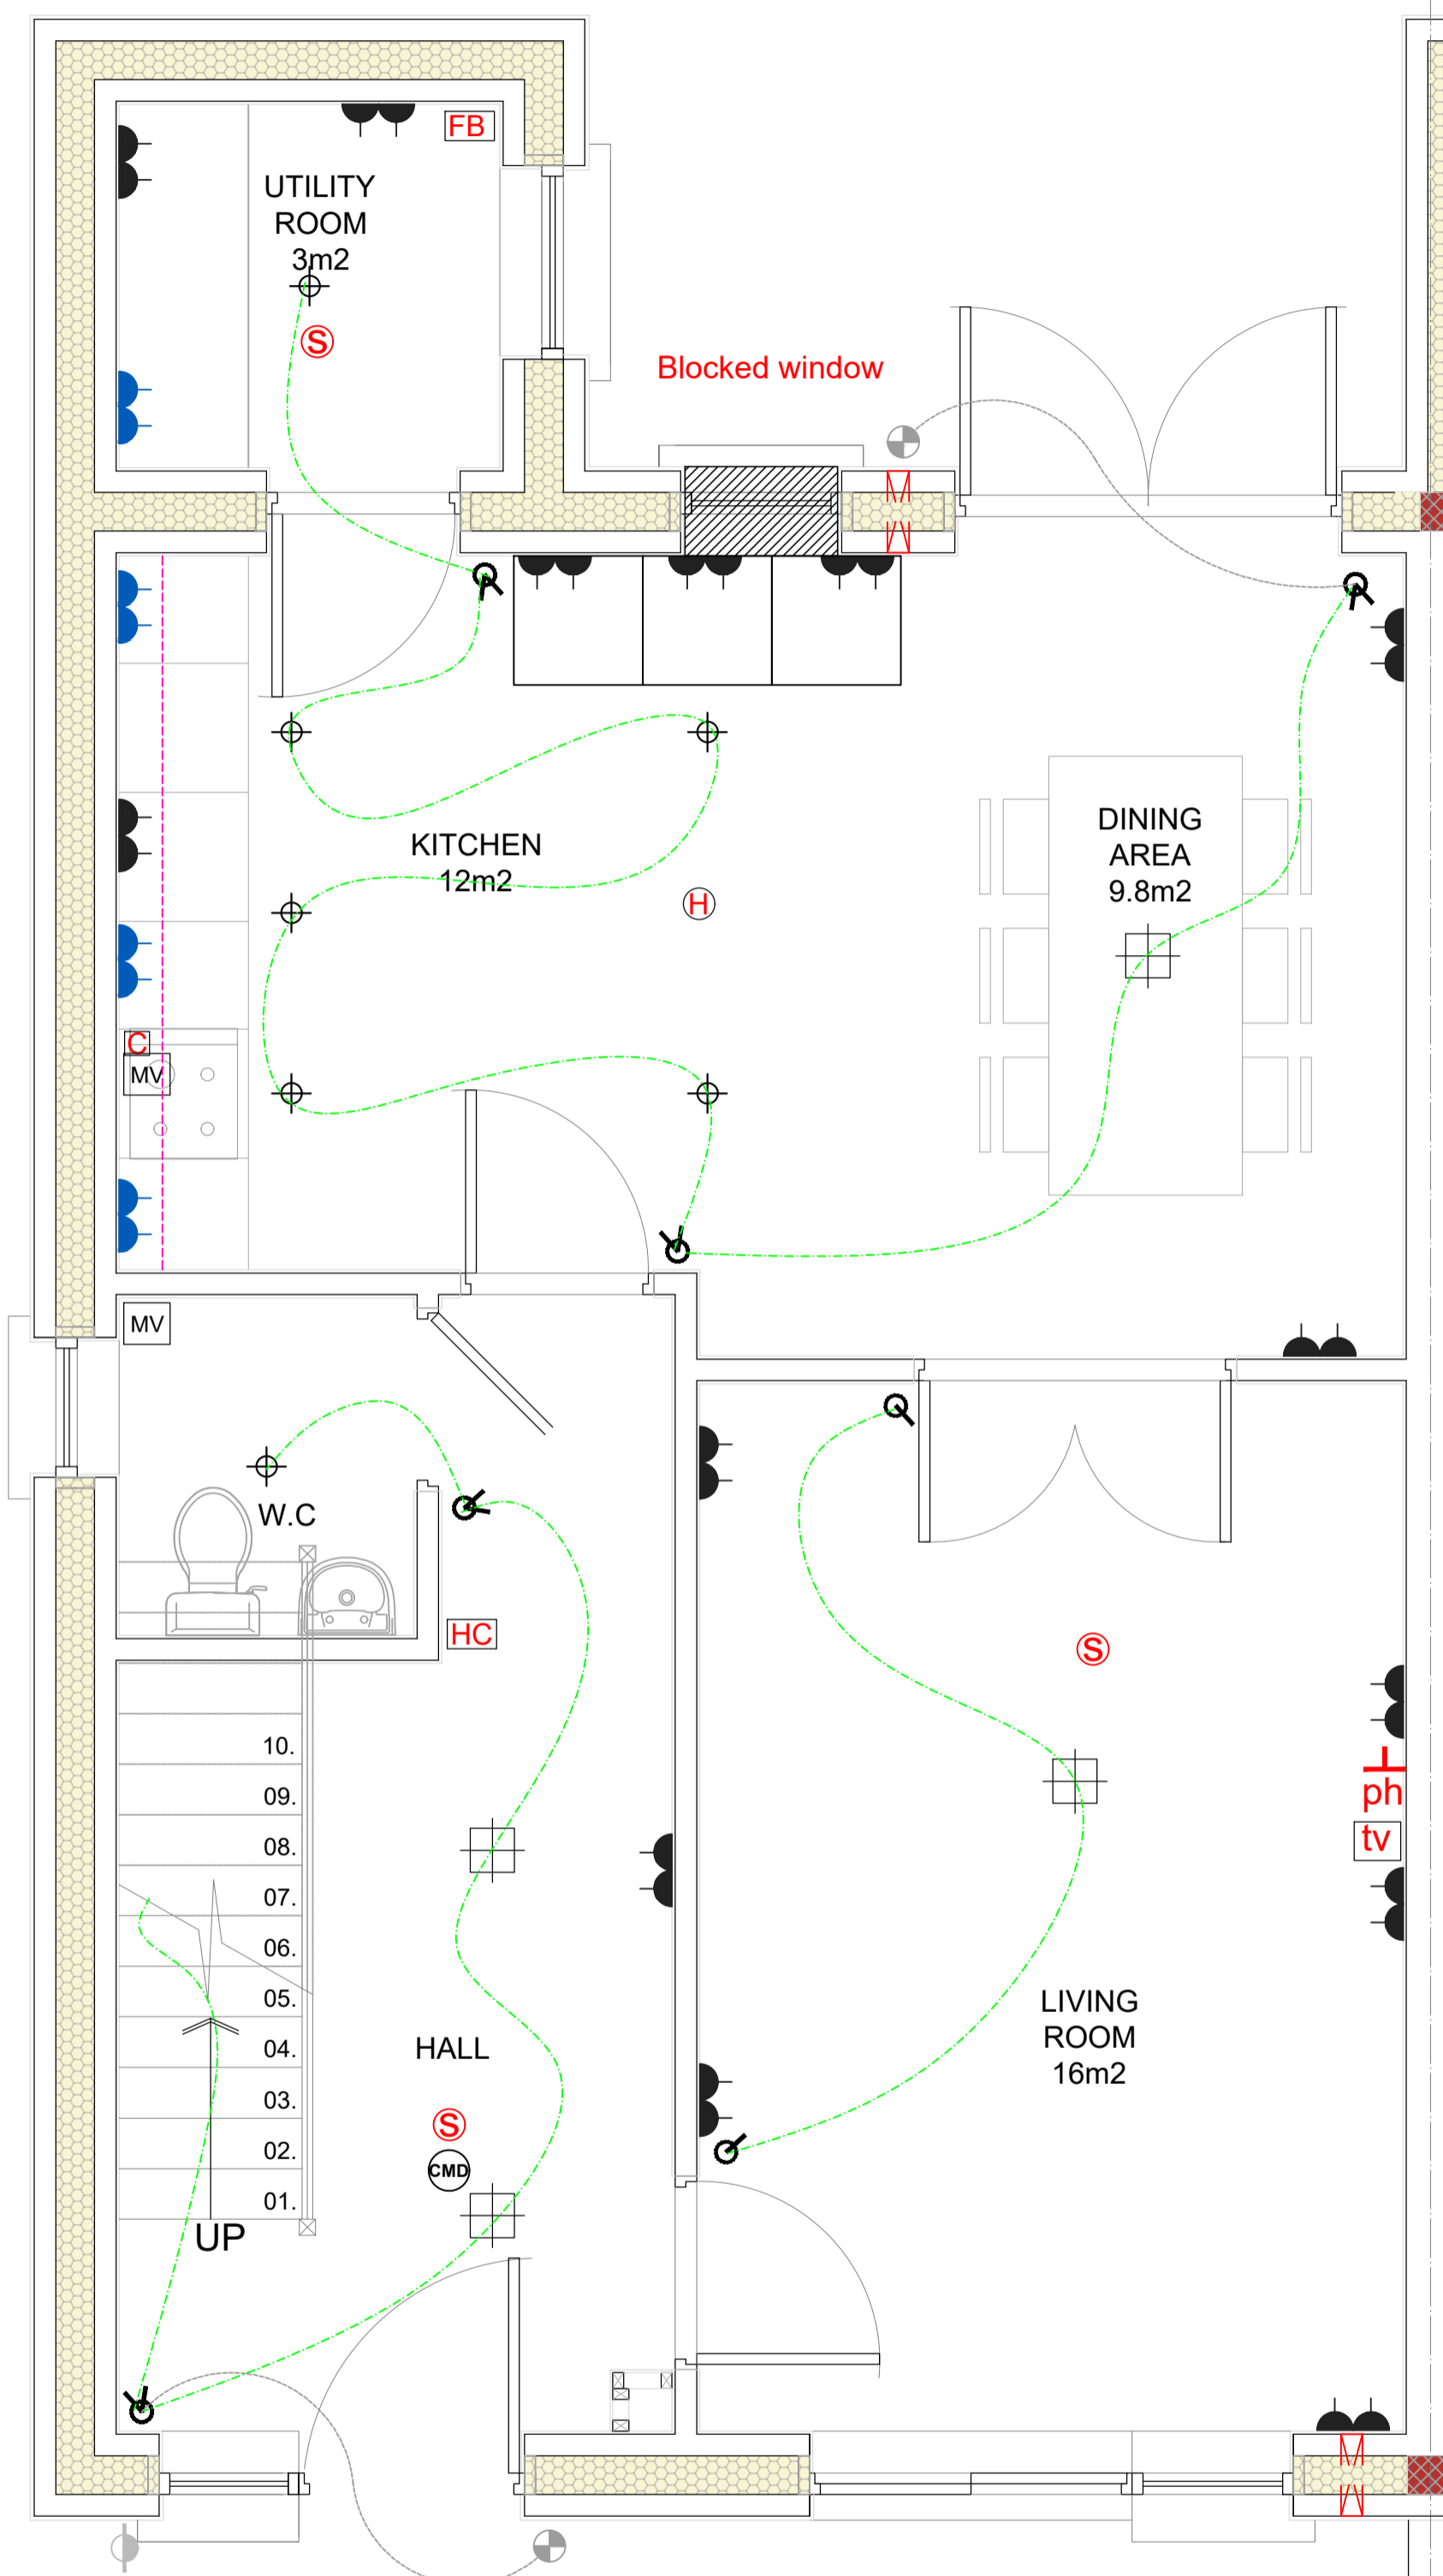

01 GROUND FLOOR PLAN
SUGGESTED RCP AND SMALL POWERS
NTS

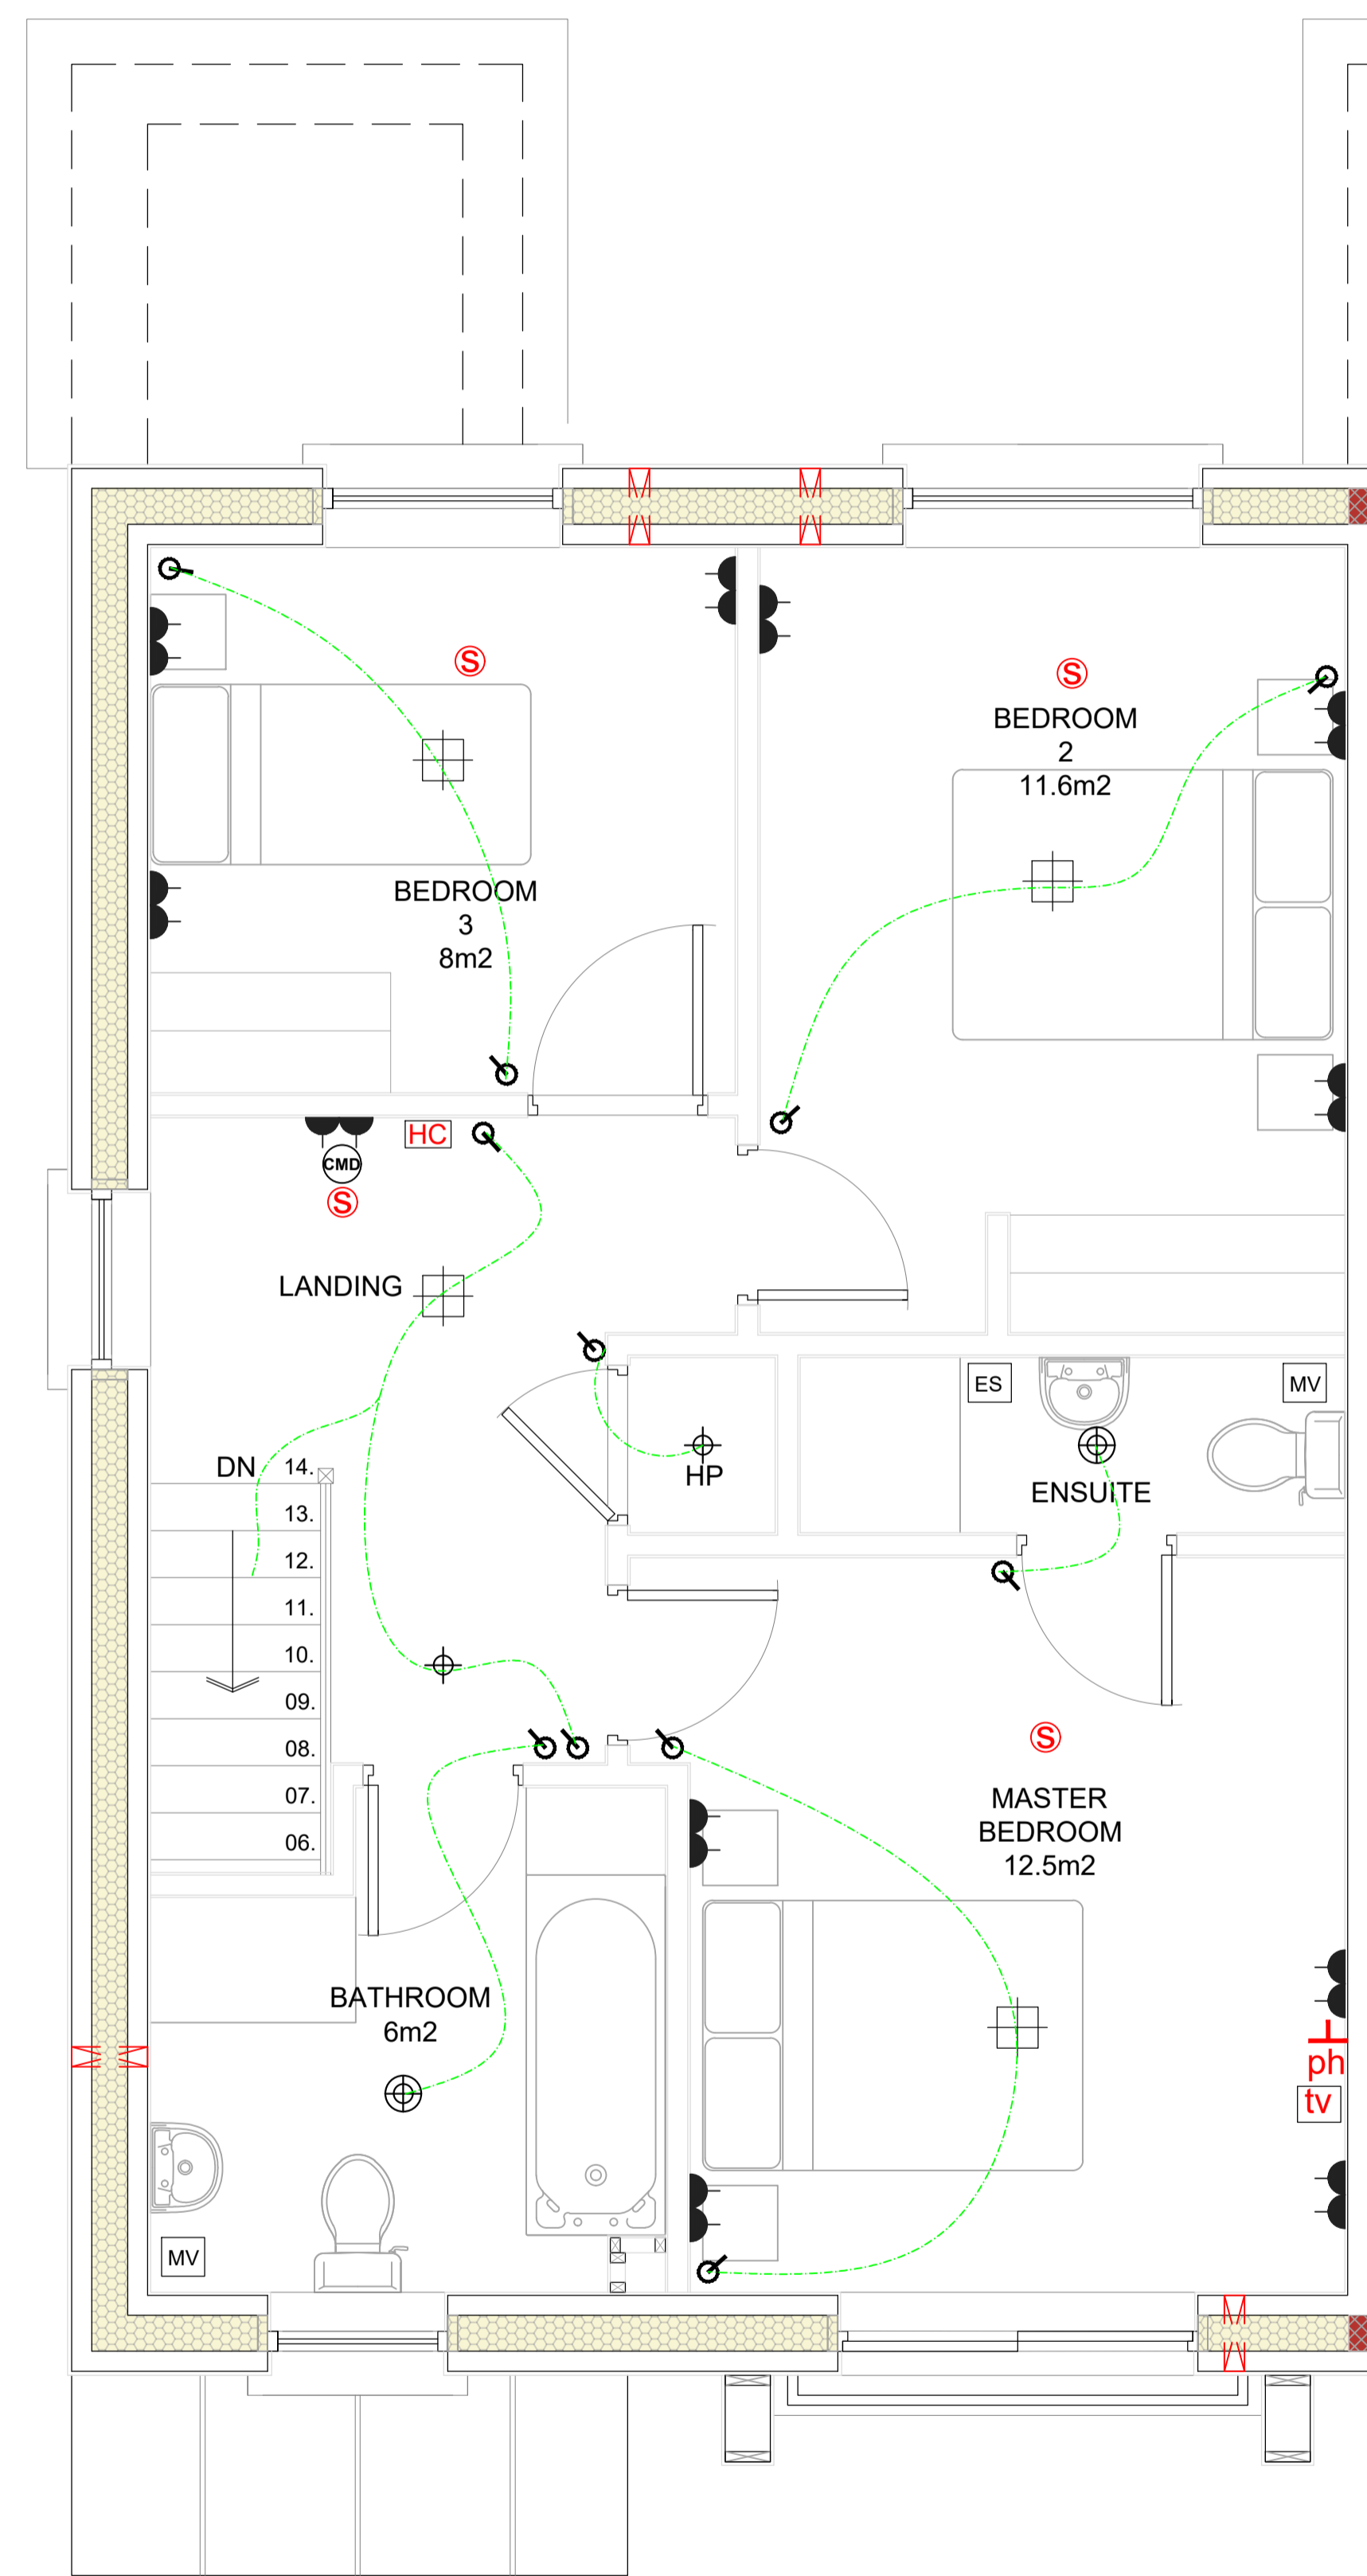

02 FIRST FLOOR PLAN
SUGGESTED RCP AND SMALL POWERS
NTS

- THIS DRAWING IS **INDICATIVE ONLY** AND SHOULD NOT BE USED FOR CONSTRUCTION PURPOSES. ELECTRICIAN OF RECORD SHOULD PROVIDE FINAL ELECTRICAL PLANS
- THIS DRAWING IS TO BE READ IN CONJUNCTION WITH ALL RELEVANT ARCHITECTS AND STRUCTURAL ENGINEERS CONSTRUCTION ISSUE DRAWINGS AND MECHANICAL AND ELECTRICAL SPECIFICATIONS
- MECHANICAL AND ELECTRICAL SERVICES TO BE COORDINATED WITH ALL OTHER TRADES AND TO BE AGREED ON SITE PRIOR TO INSTALLATION

CLIENT O' Reilly Hyland Real Estate	
PROJECT NAME The Paddocks, Coolcotts Lane, Co. Wexford	
DRAWING NAME SUGGESTED RCP and SP PLAN - HOUSE TYPE D1	
DRWG NO	DRWN/CKD BY
REV A	SCALE NTS